

Oakland Street Lofts

Renovation and Addition



9 Oakland Street Amesbury, MA 01913

March 9, 2026

SHEET NUMBER	SHEET NAME	PLANNING BOARD FILING 03.09.2026
G100	COVER	•
C-1.0	COVER SHEET	•
C-2.0	GENERAL NOTES & LEGEND	•
C-3.0	BOUNDARY PLAN	•
C-4.0	EXISTING CONDITIONS PLAN	•
C-5.0	CIVIL SITE PLAN	•
C-6.0	DEMOLITION & EROSION CONTROL PLAN	•
C-7.0	CONSTRUCITON DETAILS	•
C-7.1	CONSTRUCITON DETAILS	•
C-7.2	CONSTRUCITON DETAILS	•
C-7.3	CONSTRUCITON DETAILS	•
L-1	LANDSCAPE PLAN	•
A100	OVERALL PLAN - GROUND FLOOR	•
A101	OVERALL PLAN - LEVEL 1	•
A102	OVERALL PLAN - LEVEL 2	•
A103	OVERALL PLAN - LEVEL 3	•
A104	OVERALL PLAN - LEVEL 4	•
A105	OVERALL PLAN - LEVEL 5	•
A106	OVERALL ROOF PLAN	•
A201	EXTERIOR ELEVATIONS	•
A202	EXTERIOR ELEVATIONS	•
A203	MATERIAL BOARD	•
P100	PHOTOMETRIC STUDY	•
P101	PHOTOMETRIC STUDY	•
R100	RENDERING	•
R101	RENDERING	•
R102	RENDERING	•
R103	RENDERING	•
R104	RENDERING	•
R105	RENDERING	•
R106	RENDERING	•
R107	RENDERING	•
R108	RENDERING	•
R109	RENDERING	•
R110	RENDERING	•



PROJECT TEAM:

9 OAKLAND STREET
AMESBURY LLC

OWNER

PO BOX 999
DANVILLE, NH 03819
978-815-1853

LAW OFFICE OF
JEFFREY L. ROELOFS, PC

ATTORNEY

44 Merrimac Street
Newburyport, MA 01950
978-462-7600

SV DESIGN LLC

ARCHITECT

126 Dodge Street
Beverly, MA 01915
978-927-3745

MILLENNIUM ENGINEERING,
INC.

CIVIL ENGINEERING

62 Elm Street
Salisbury, MA 01952
978-462-8980

JAMES K. EMMANUEL
ASSOCIATES

LANDSCAPE ARCHITECT

22 Carlton Road
Marblehead, MA 01945
978-622-7487

SV
DESIGN

COVER


9 OAKLAND STREET AMESBURY LLC
9 Oakland Street Amesbury, MA 01913
SV DESIGN 126 Dodge Street Beverly, Massachusetts 01915 www.svdesign.com t 978.927.3745

March 9, 2026

Revisions
Issue Date Description
Checked By
Scale: 3/16" = 1'-0"
Drawn By: Author
Date: March 9, 2026
Checked By: Checker
Project #: 116122.007

COVER

G100

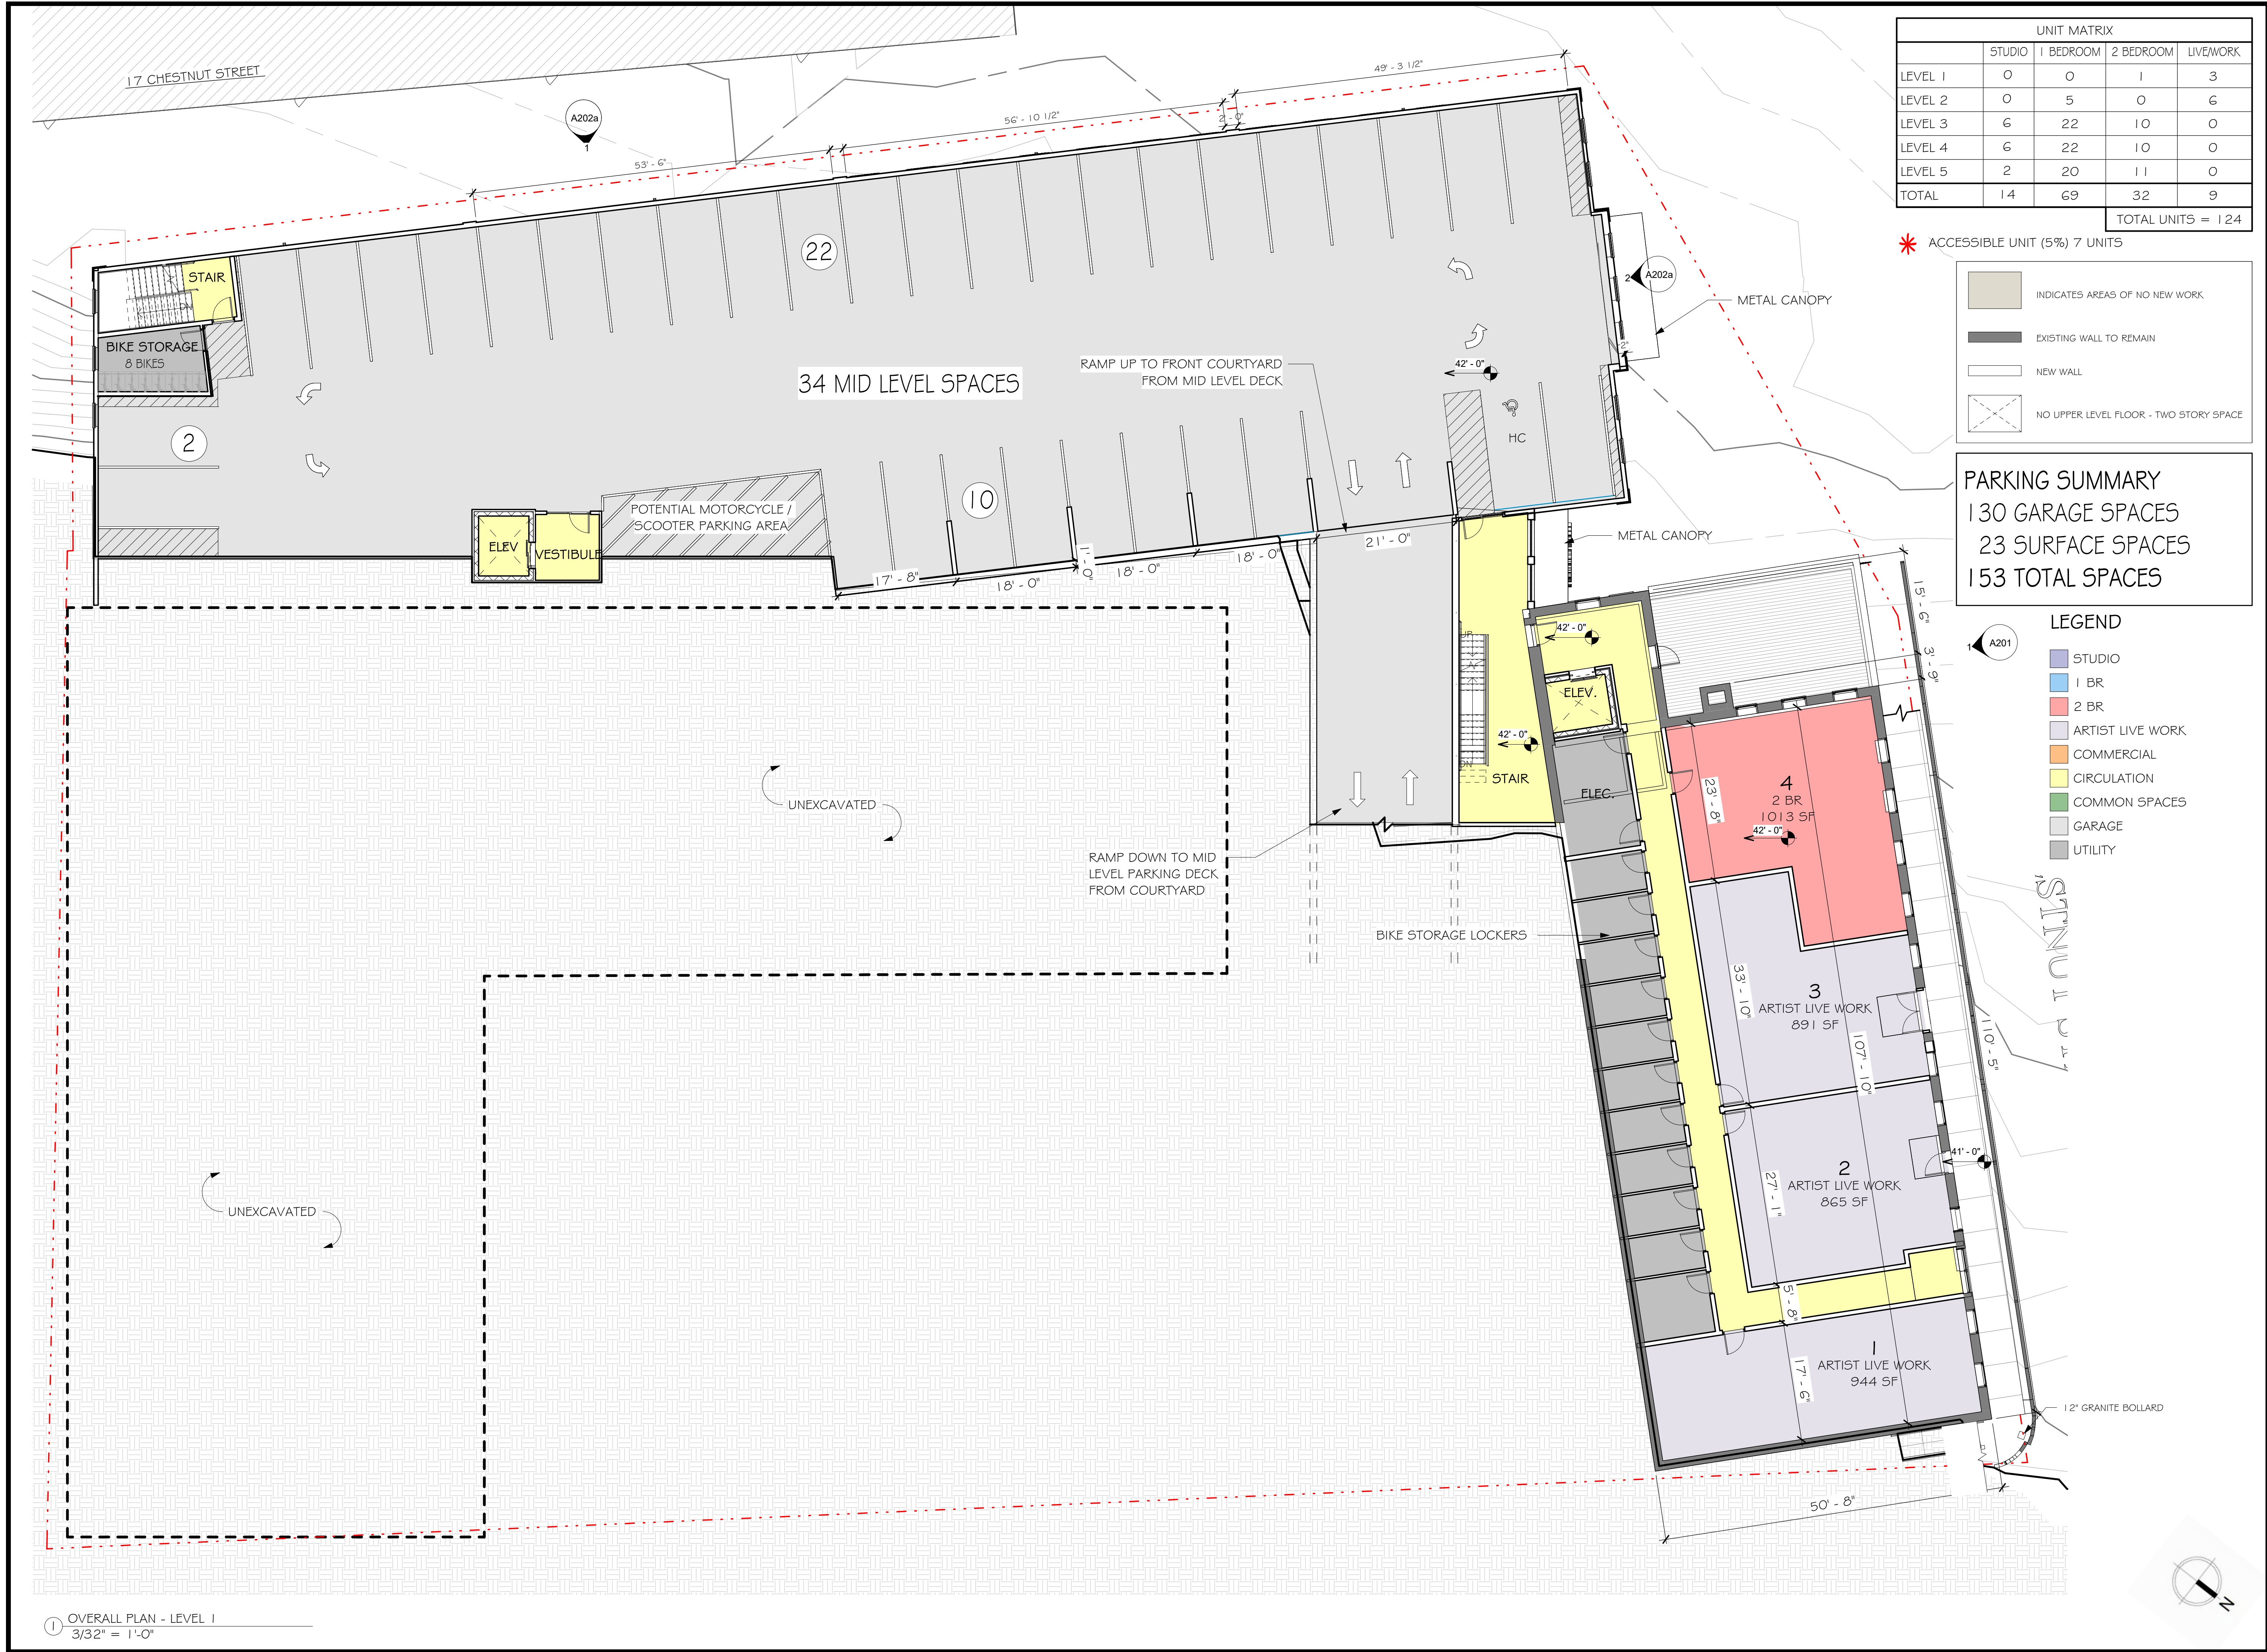

March 9, 2026

Checked By

Revisions

Issue Date

Description

OVERALL PLAN - LEVEL 1

Scale: As indicated

Drawn By: Author

Date: March 9, 2026

Checked By: Checker

Project #: 116122.007

Proposed Renovations

9 OAKLAND STREET AMESBURY LLC

9 Oakland Street Amesbury, MA 01913

SV DESIGN

126 Dodge Street

Beverly, Massachusetts 01915

www.svdesign.com

1975.927.3745

DESIGN

© SV Design, LLC.

OVERALL PLAN - LEVEL 1

A101





March 9, 2026
Checked By

Issue Date:
Description

Revisions

Scale: As indicated
Drawn By: Author
Date: March 9, 2026

Checked By: Checker
Project #: 116122.007

 
Proposed Renovation





9 OAKLAND STREET AMESBURY LLC
9 Oakland Street Amesbury, MA 01913

SVY DESIGN 126 Dodge Street
Beverly, Massachusetts 01915
www.svdesign.com
t 978.927.3745

OVERALL PLAN - LEVEL 5

A105



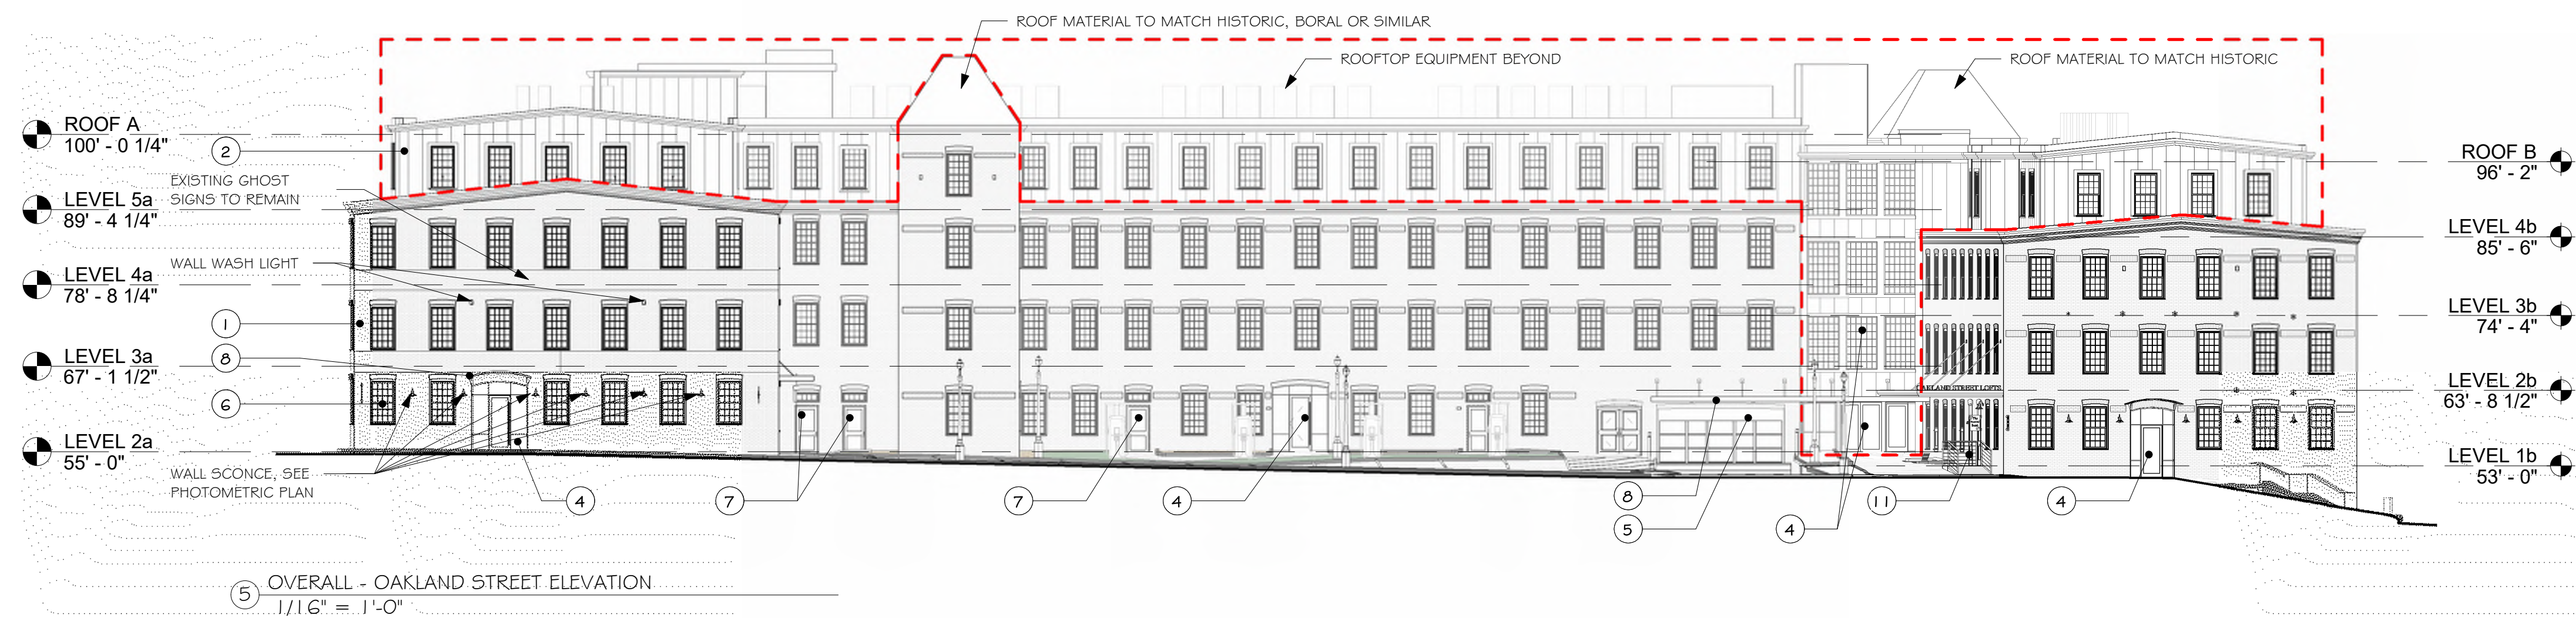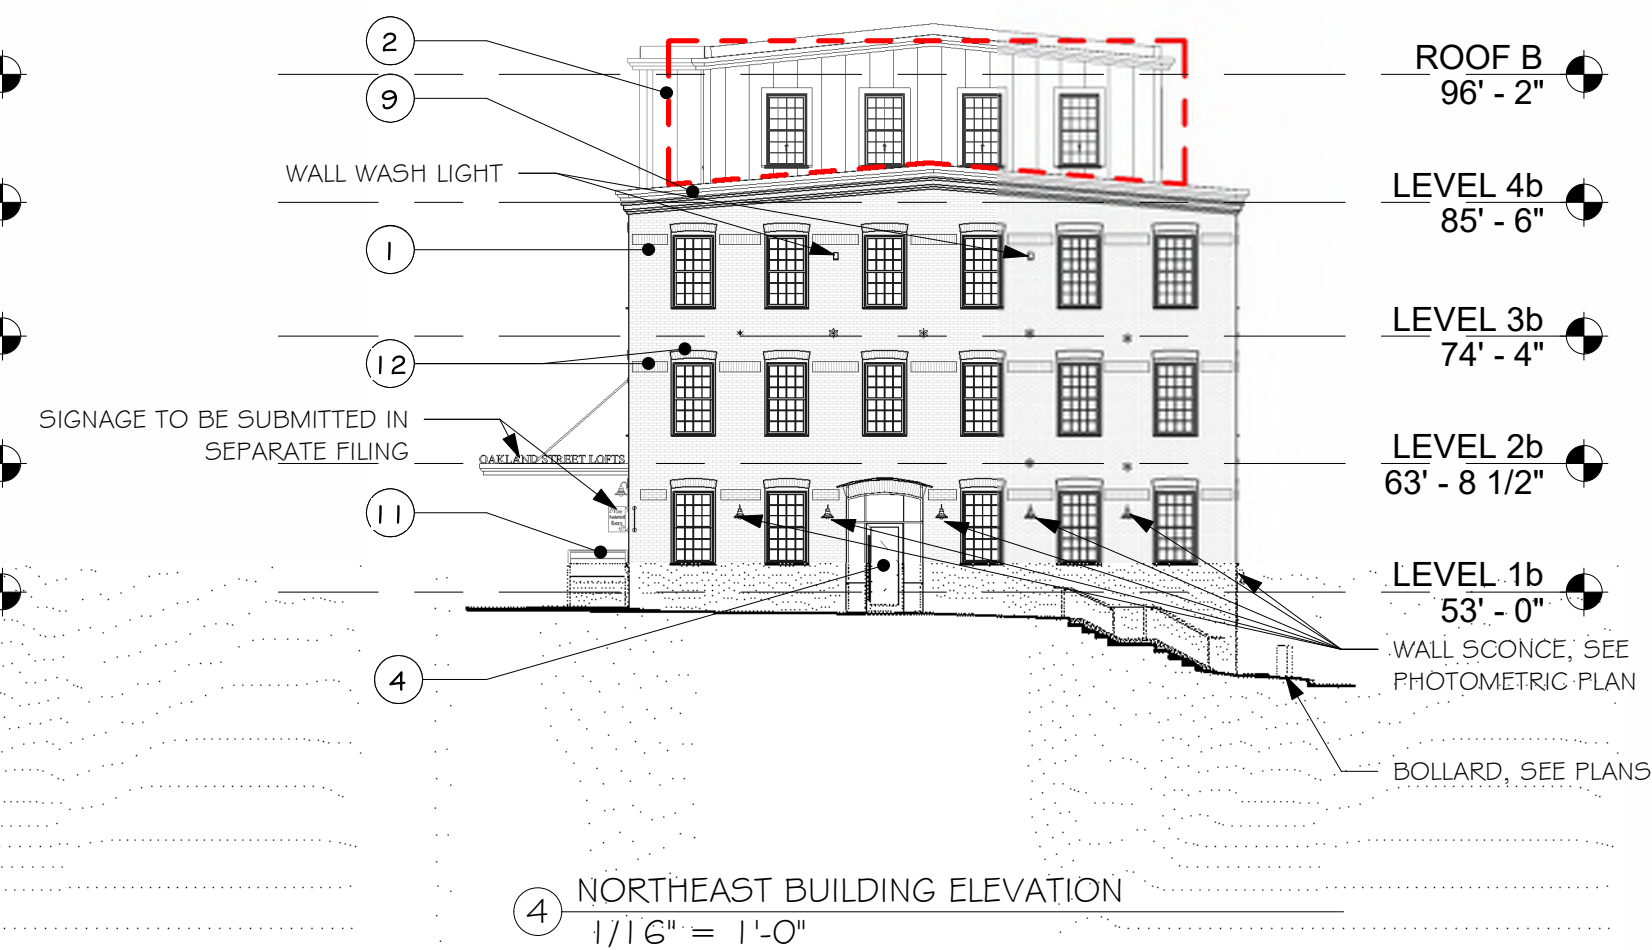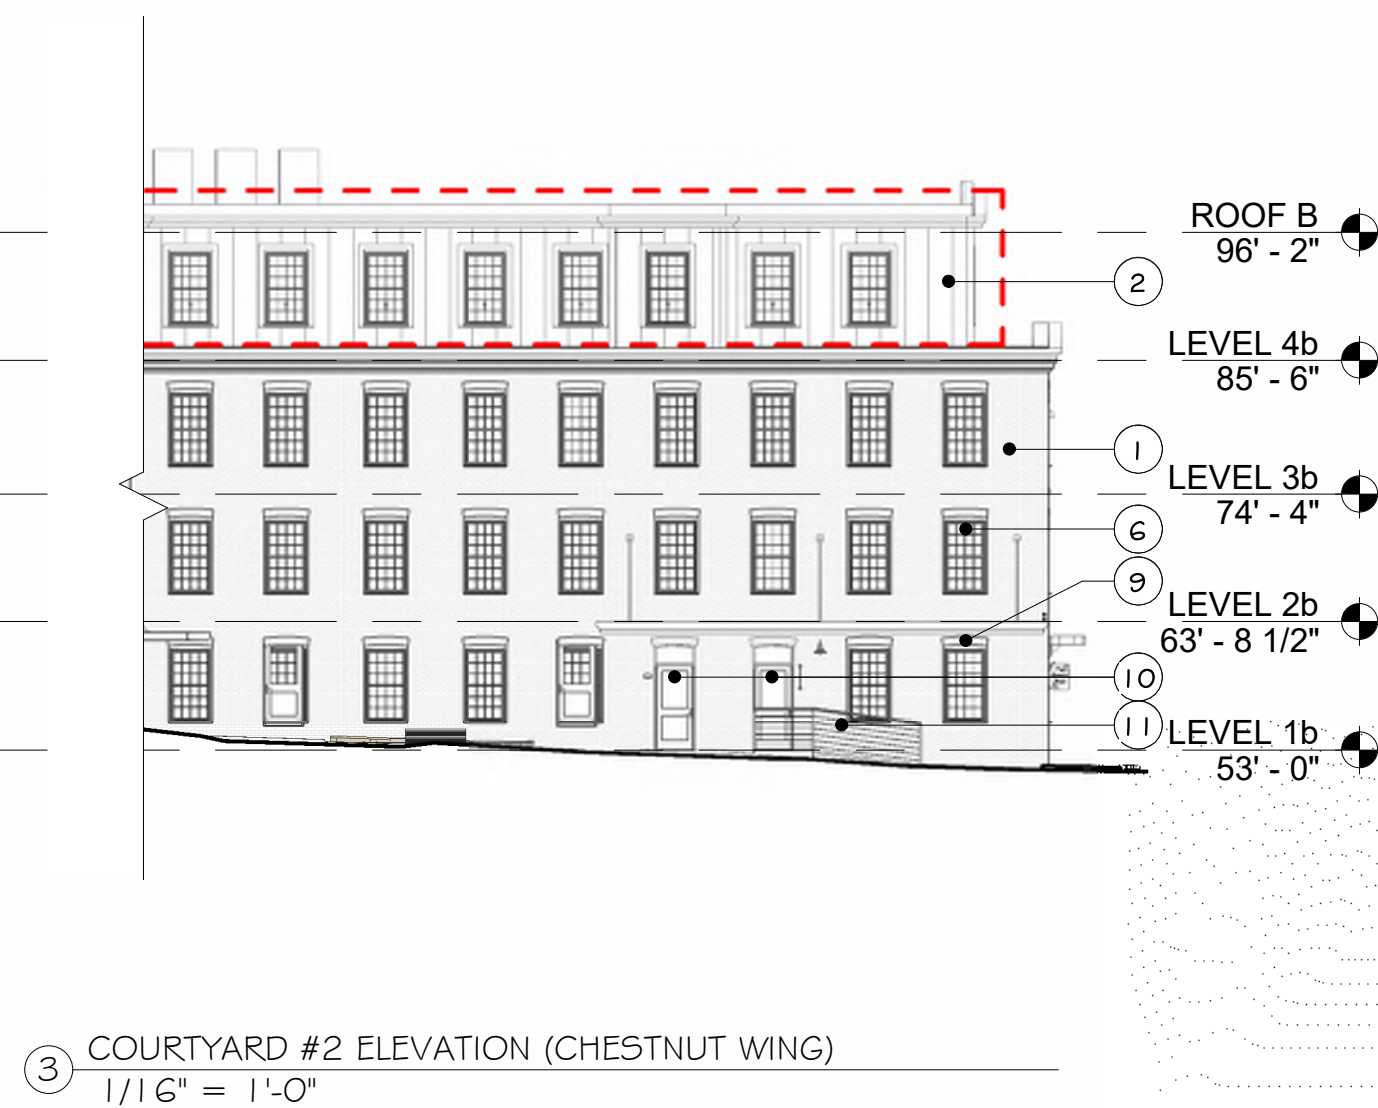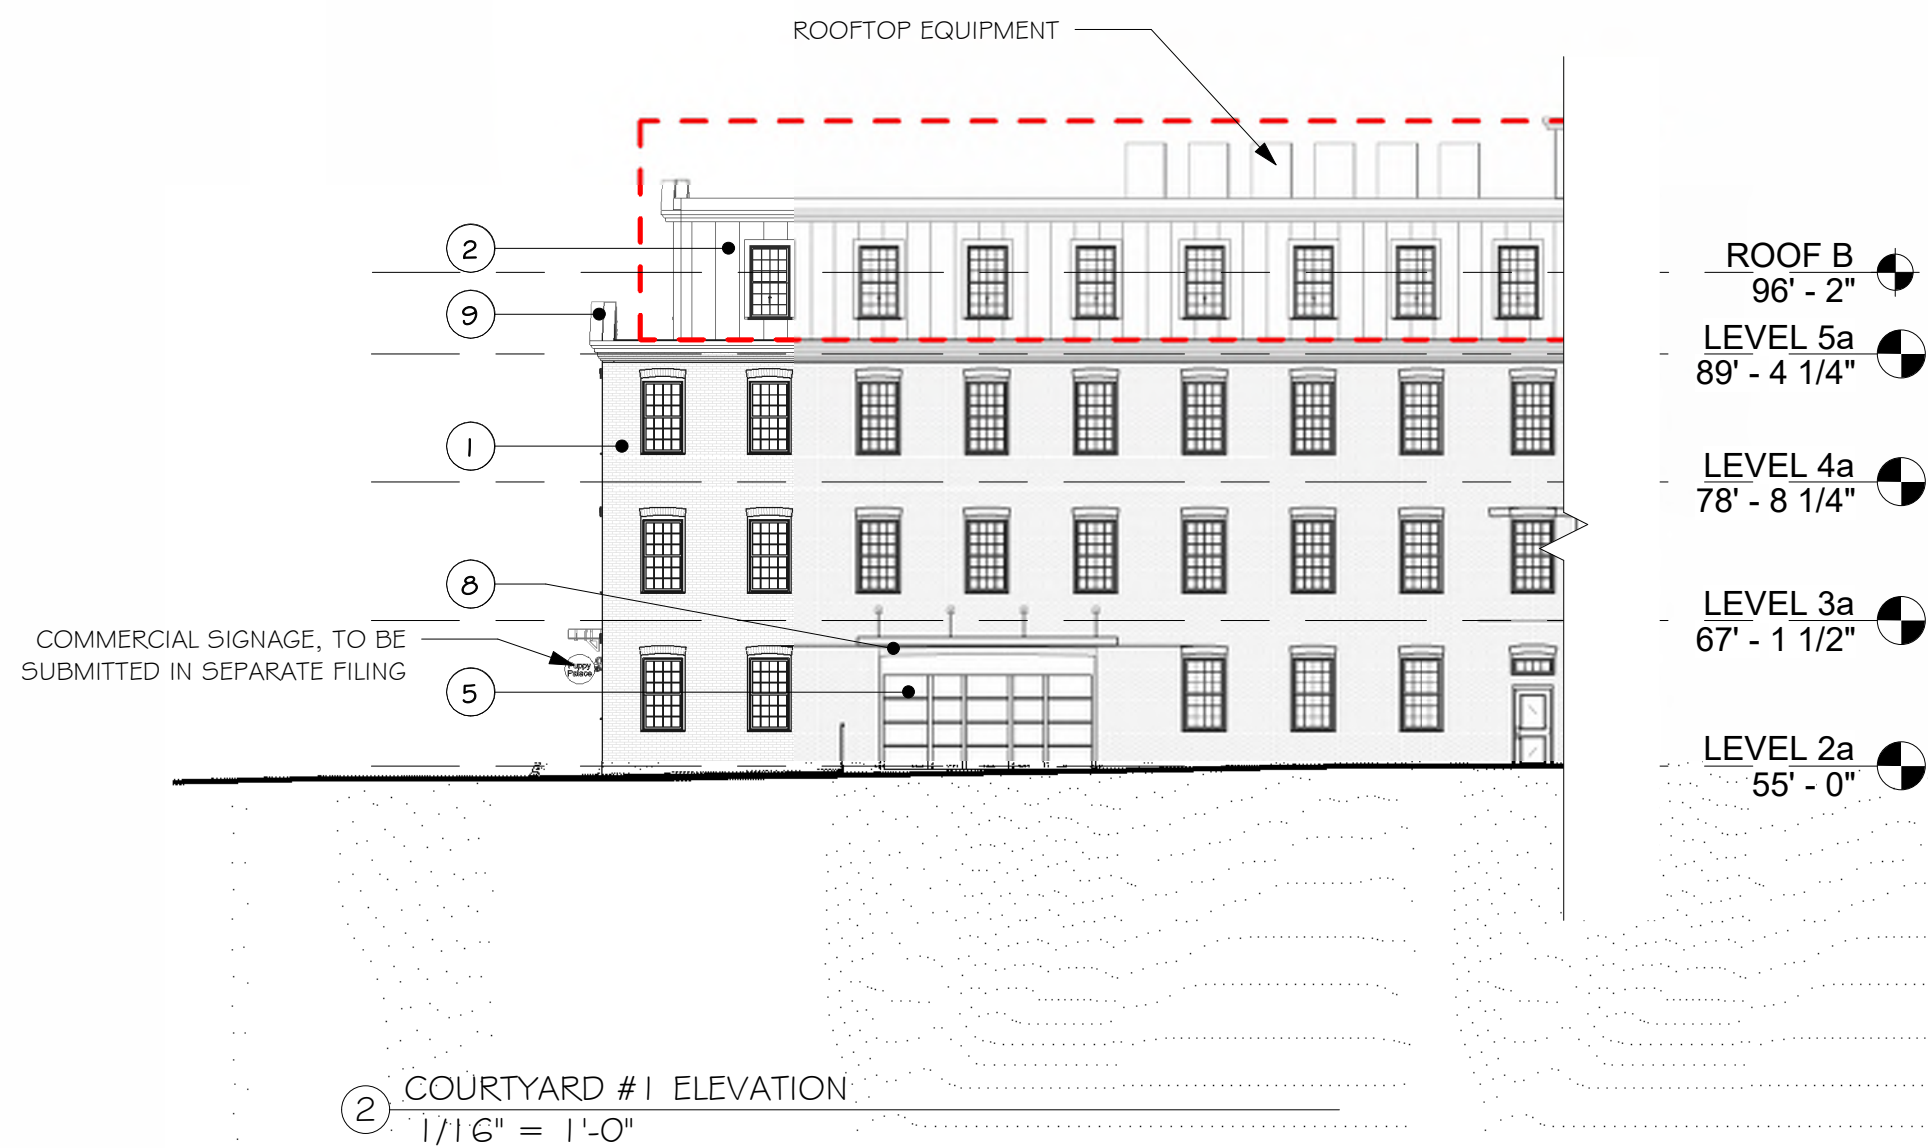


EXTERIOR ELEVATION KEYNOTES	
NUMBER	ITEM
1	EXISTING BRICK TO REMAIN, PATCH AND REPAIR AS NEEDED.
2	CORRUGATED METAL PANEL, PAC-150, 180 DEGREE SEAM OR SIMILAR COLOR: TBD
3	ART INSTALLATION, PRECAST FRAME W/ WALL SCONCE ABOVE
4	ALUMINUM STOREFRONT SYSTEM, COLOR: BLACK
5	GARAGE DOOR
6	DOUBLE HUNG WINDOWS, SASH BLACK
7	FULL LITE GLASS DOOR
8	BLACK CANOPY
9	EXISTING CORNICE TO REMAIN, PATCH AND REPAIR AS NEEDED.
10	HALF LITE GLASS DOOR
11	METAL RAILING, COLOR: BLACK
12	EXISTING BRICK DETAILS TO REMAIN, PATCH AND REPAIR AS NEEDED.
13	NEW BRICK TO MATCH EXISTING

EXTERIOR ELEVATIONS

9 OAKLAND STREET AMESBURY LLC
9 Oakland Street Amesbury, MA 01913

SV DESIGN

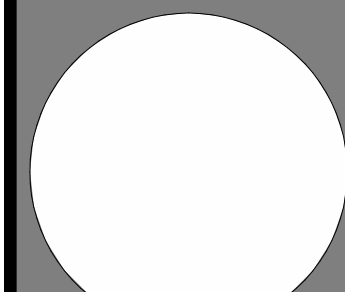

EXTERIOR ELEVATIONS

A201

Proposed Renovation

March 9, 2026

Revisions

Issue Date

Description

Checked By

Project #

Scale: 1/16" = 1'-0"

Drawn By: Author

Checked By: Checker

Date: March 9, 2026

Project # 116122007

1975.927.3745

Beverly, Massachusetts 01915

www.svdesign.com

126 Dodge Street

SV DESIGN

EXTERIOR ELEVATION KEYNOTES	
NUMBER	ITEM
1	EXISTING BRICK TO REMAIN, PATCH AND REPAIR AS NEEDED.
2	CORRUGATED METAL PANEL, PAC-150, 180 DEGREE SEAM OR SIMILAR COLOR: TBD
3	ART INSTALLATION, PRECAST FRAME W/ WALL SCONCE ABOVE
4	ALUMINUM STOREFRONT SYSTEM, COLOR: BLACK
5	GARAGE DOOR
6	DOUBLE HUNG WINDOWS, SASH BLACK
7	FULL LITE GLASS DOOR
8	BLACK CANOPY
9	EXISTING CORNICE TO REMAIN, PATCH AND REPAIR AS NEEDED.
10	HALF LITE GLASS DOOR
11	METAL RAILING, COLOR: BLACK
12	EXISTING BRICK DETAILS TO REMAIN, PATCH AND REPAIR AS NEEDED.
13	NEW BRICK TO MATCH EXISTING

RED DASH INDICATES
PROPOSED ADDITIONS, TYP.

② SOUTHEAST BUILDING ELEVATION
1/16" = 1'-0"


ROOFTOP EQUIPMENT

① SOUTHWEST BUILDING ELEVATION - GARAGE ADDITION
1/16" = 1'-0"

EXTERIOR ELEVATIONS

Proposed Renovation

9 OAKLAND STREET AMESBURY LLC
9 Oakland Street Amesbury, MA 01913

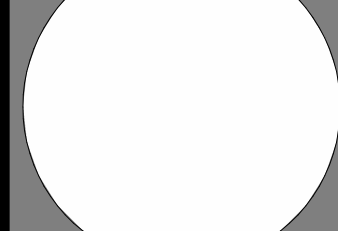

EXTERIOR ELEVATIONS

A202

Revisions
Issue Date: Description

March 9, 2026
Checked By:

Scale: 1/16" = 1'-0"
Drawn By: Author
Date: March 9, 2026

Checked By: Checker
Project #: 116122.007

www.svdesign.com

Beverly, Massachusetts 01915

126 Dodge Street

SV DESIGN



VIEW FROM OAKLAND STREET

Proposed Renovation

SV DESIGN126 Dodge StreetBeverly, Massachusetts 01915www.svdesign.comt 978.927.3745

DESIGN

RENDERING

R100

RENDERING

Scale: 1/4" = 1'-0"
Drawn By: Author
Date: March 9, 2026

Checked By: Checker
Project #: 116122.007

Revisions

Issue Date: Description

March 9, 2026

Checked By:

Autodesk Docs://Sweet- Amesbury/Sweet Mgmt_Oakland St- Amesbury_R21.rvt3/9/2026 10:41:13 AM



VIEW FROM OAKLAND STREET

SV DESIGN

© SV Design, LLC.

RENDERING

Proposed Renovation

9 OAKLAND STREET AMESBURY LLC

9 Oakland Street Amesbury, MA 01913

SV DESIGN 126 Dodge Street Beverly, Massachusetts 01915 www.svdesign.com 1975.927.3745

RENDERING

Scale: 1/4" = 1'-0"

Drawn By: Author

Date: March 9, 2026

Checked By: Checker

Project #: 116122.007

Revisions	Issue Date	Description	Checked By

March 9, 2026



VIEW FROM OAKLAND STREET

SV DESIGN

© SV Design, LLC.

RENDERING

Proposed Renovation

9 OAKLAND STREET AMESBURY LLC

9 Oakland Street Amesbury, MA 01913

SV DESIGN 126 Dodge Street Beverly, Massachusetts 01915 www.svdesign.com t 978.927.3745

RENDERING

Scale: 1/4" = 1'-0"

Drawn By: Author

Date: March 9, 2026

Checked By: Checker

Project #: 116122.007

Revisions	Issue Date	Description	Checked By

March 9, 2026



VIEW FROM OAKLAND STREET

SV DESIGN

© SV Design, LLC.

RENDERING

Proposed Renovation

9 OAKLAND STREET AMESBURY LLC

9 Oakland Street Amesbury, MA 01913

SV DESIGN 126 Dodge Street Beverly, Massachusetts 01915 www.svdesign.com t 978.927.3745

RENDERING

Scale: 1/4" = 1'-0"

Drawn By: Author

Date: March 9, 2026

Checked By: Checker

Project #: 116122.007

Revisions

Issue Date: Description: Checked By:

March 9, 2026



VIEW FROM CORNER OF OAKLAND AND CHESTNUT STREET

SV DESIGN

© SV Design, LLC.

RENDERING

Proposed Renovation

9 OAKLAND STREET AMESBURY LLC

9 Oakland Street Amesbury, MA 01913

SV DESIGN 126 Dodge Street Beverly, Massachusetts 01915 www.svdesign.com t 978.927.3745

RENDERING

Scale: 1/4" = 1'-0"

Drawn By: Author

Date: March 9, 2026

Checked By: Checker

Project #: 116122.007

Revisions

Issue Date: Description

March 9, 2026

Checked By:



VIEW FROM CHESTNUT STREET

SV DESIGN

DESIGN

© SV Design, LLC.

Proposed Renovation

9 OAKLAND STREET AMESBURY LLC

9 Oakland Street Amesbury, MA 01913

SV DESIGN 126 Dodge Street Beverly, Massachusetts 01915 www.svdesign.com 1975.927.3745

RENDERING

RENDERING

R105

Revisions

March 9, 2026

Issue Date

Checked By

Issue Date

Description

Checked By

Scale: 1/4" = 1'-0"

Drawn By: Author

Checked By: Checker

Date: March 9, 2026

Project #: 116122.007



CHESTNUT STREET COMMERCIAL SPACE

RENDERING		March 9, 2026
9 OAKLAND STREET AMESBURY LLC		
9 Oakland Street Amesbury, MA 01913		
SV DESIGN	126 Dodge Street Beverly, Massachusetts 01915 www.svdesign.com	1975.927.3745
DESIGN		
RENDERING		
R106		
Revisions		Issue Date: Description: Checked By:
Scale: 1/4" = 1'-0"		Drawn By: Author
Date: March 9, 2026		Checked By: Checker
		Project #: 116122.007



VIEW FROM CHESTNUT STREET





COURTYARD VIEW

SV DESIGN

DESIGN

© SV Design, LLC.

RENDERING

R109

9 OAKLAND STREET AMESBURY LLC
9 Oakland Street Amesbury, MA 01913

SV DESIGN 126 Dodge Street
Beverly, Massachusetts 01915
1975.927.3745
www.svdesign.com

RENDERING

Scale: 3" = 1'-0"
Drawn By: Author
Date: March 9, 2026

Checked By: Checker
Project #: 116122.007

Revisions

Issue Date: Description

March 9, 2026

Checked By:



VIEW FROM CORNER OF OAKLAND AND CHESTNUT STREET

SV DESIGN

DESIGN

© SV Design, LLC.

RENDERING

R110

9 OAKLAND STREET AMESBURY LLC

9 Oakland Street Amesbury, MA 01913

SV DESIGN 126 Dodge Street Beverly, Massachusetts 01915 www.svdesign.com 1975.927.3745

RENDERING

Scale: 3" = 1'-0"

Drawn By: Author

Date: March 9, 2026

Checked By: Checker


Project #: 116122.007

Revisions

Issue Date: Description

March 9, 2026

Checked By:

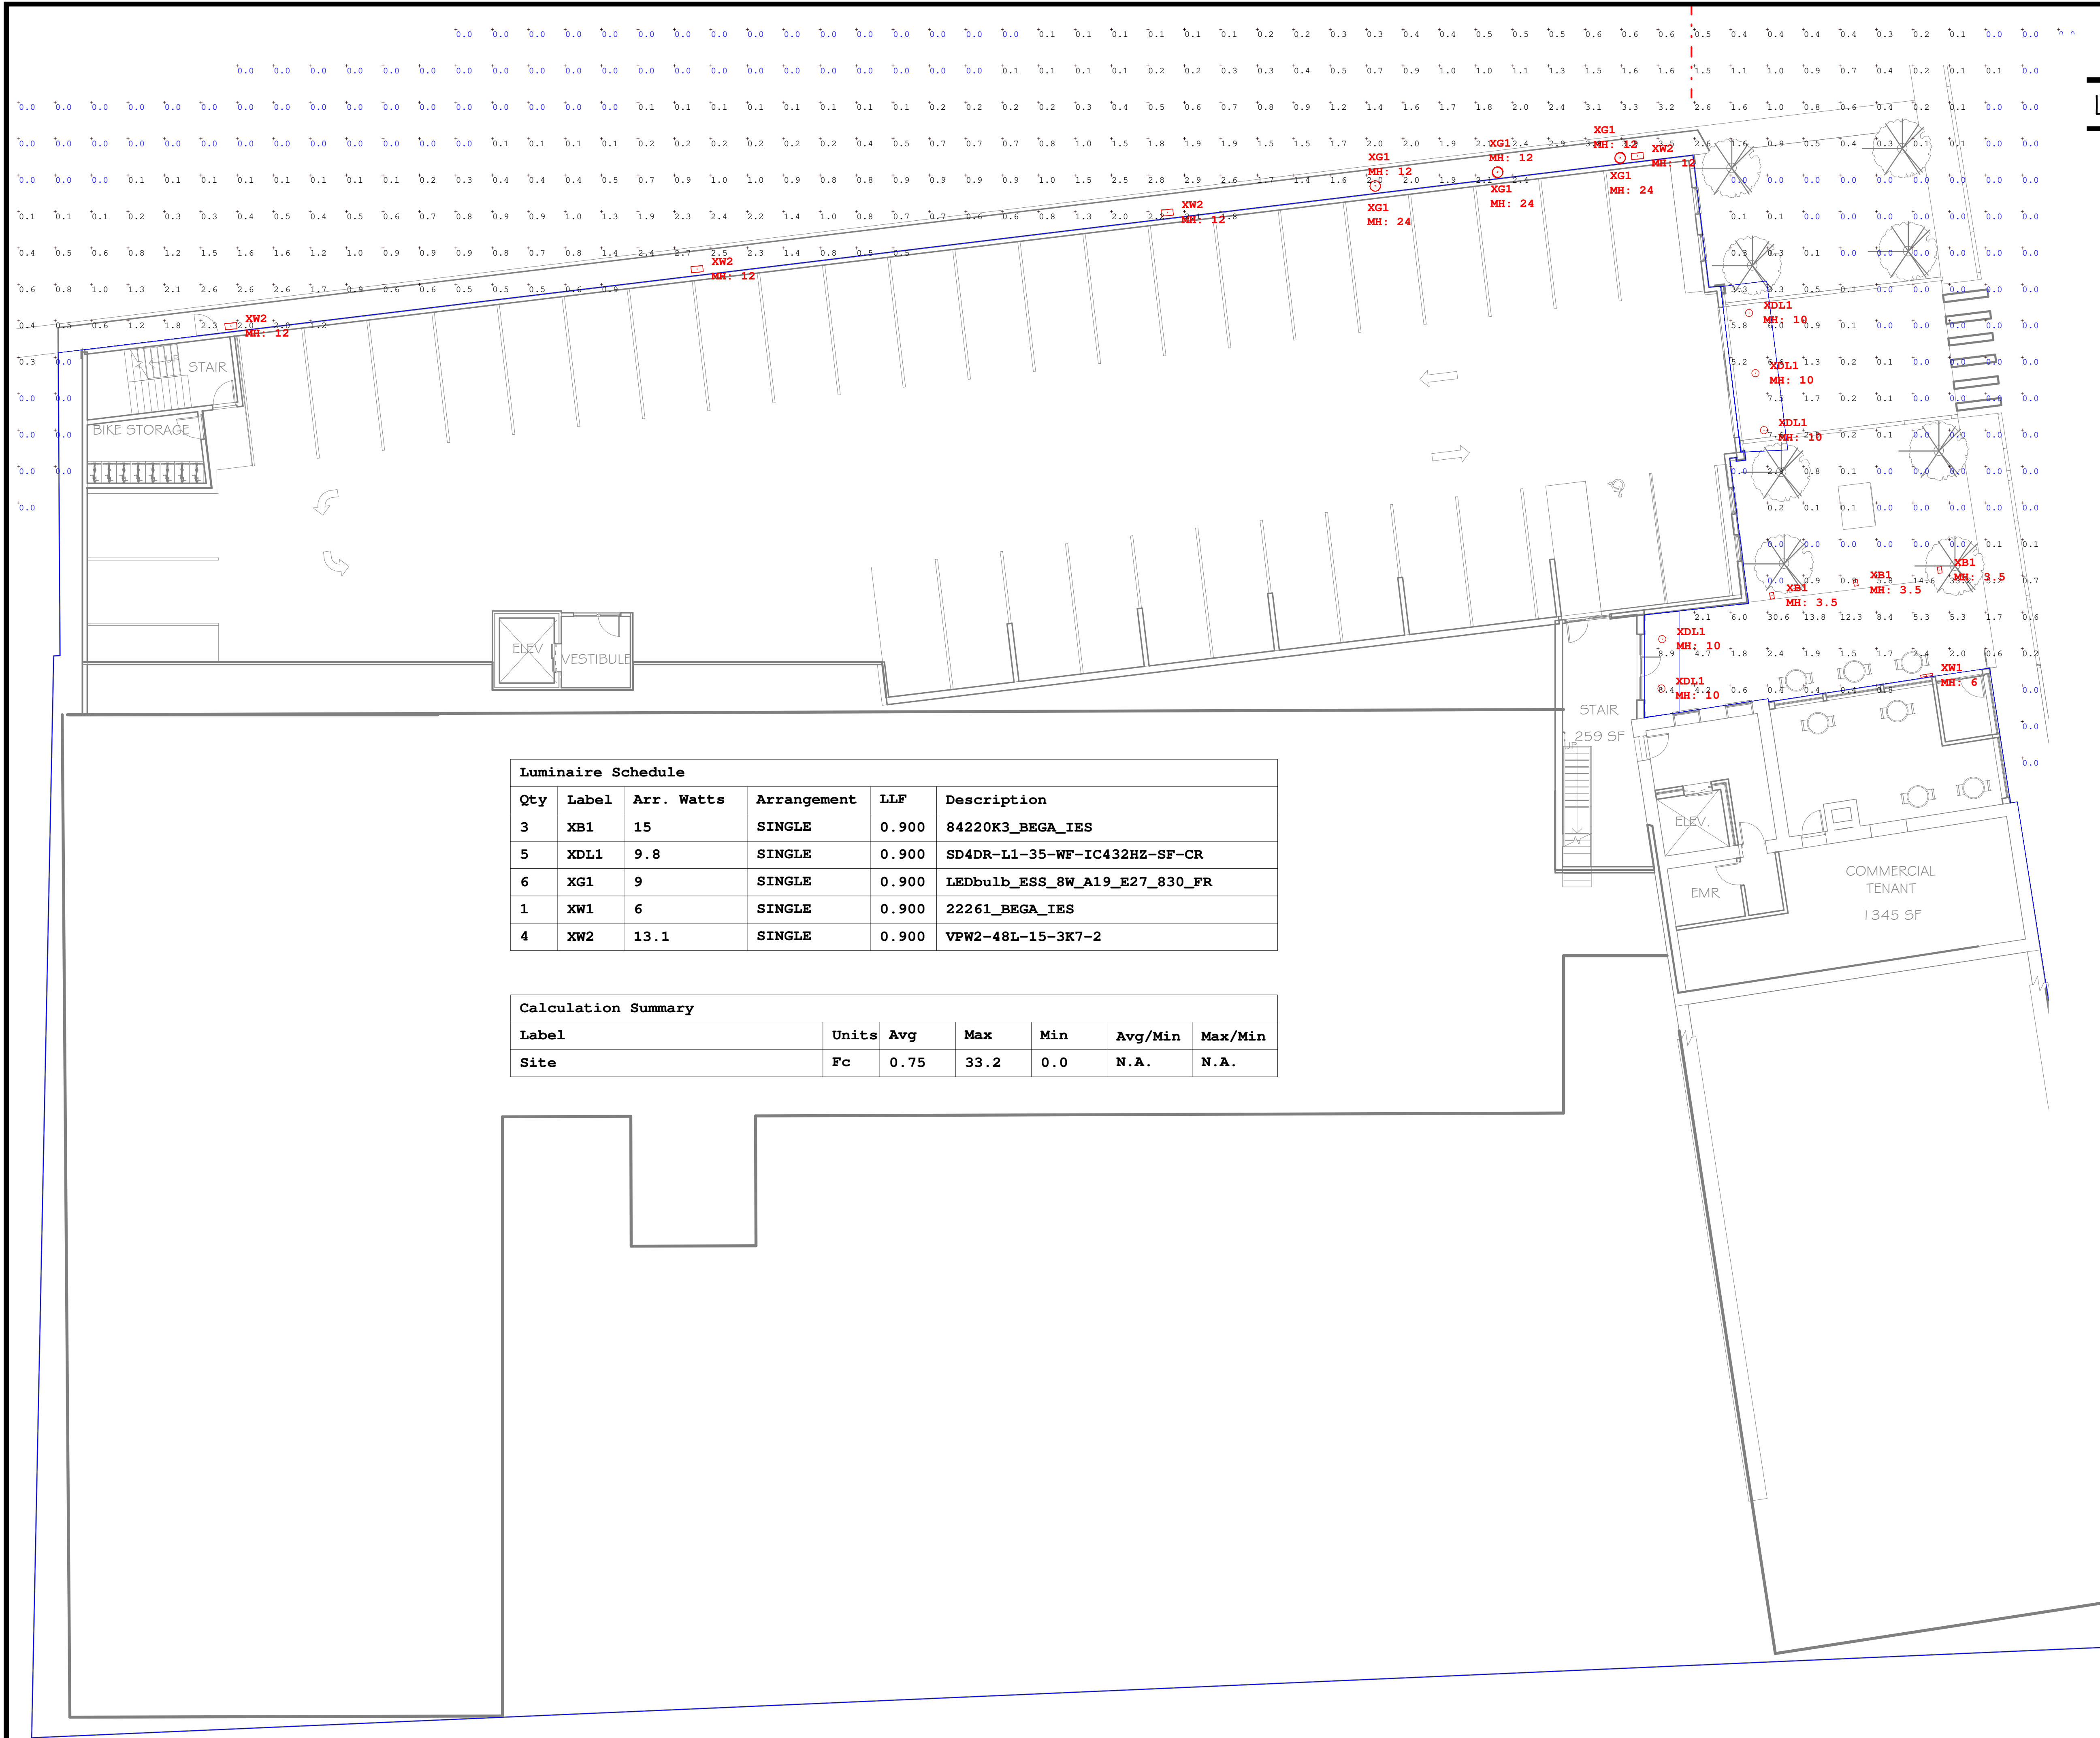

Luminaire Schedule					
Qty	Label	Arr. Watts	Arrangement	LLF	Description
3	XB1	15	SINGLE	0.900	84220K3_BEGA_IES
5	XDL1	9.8	SINGLE	0.900	SD4DR-L1-35-WF-IC432HZ-SF-CR
6	XG1	9	SINGLE	0.900	LEDbulb_ESS_8W_A19_E27_830_FR
1	XW1	6	SINGLE	0.900	22261_BEGA_IES
4	XW2	13.1	SINGLE	0.900	VPW2-48L-15-3K7-2

Calculation Summary						
Label	Units	Avg	Max	Min	Avg/Min	Max/Min
Site	Fc	0.75	33.2	0.0	N.A.	N.A.

LIGHT FIXTURES

4" LED DOWNLIGHT - XDL1


WALL SCONCE - XW1

WALL SCONCE - XW2

BOLLARD- XB1

WALL WASH

WALL SCONCE- XG1

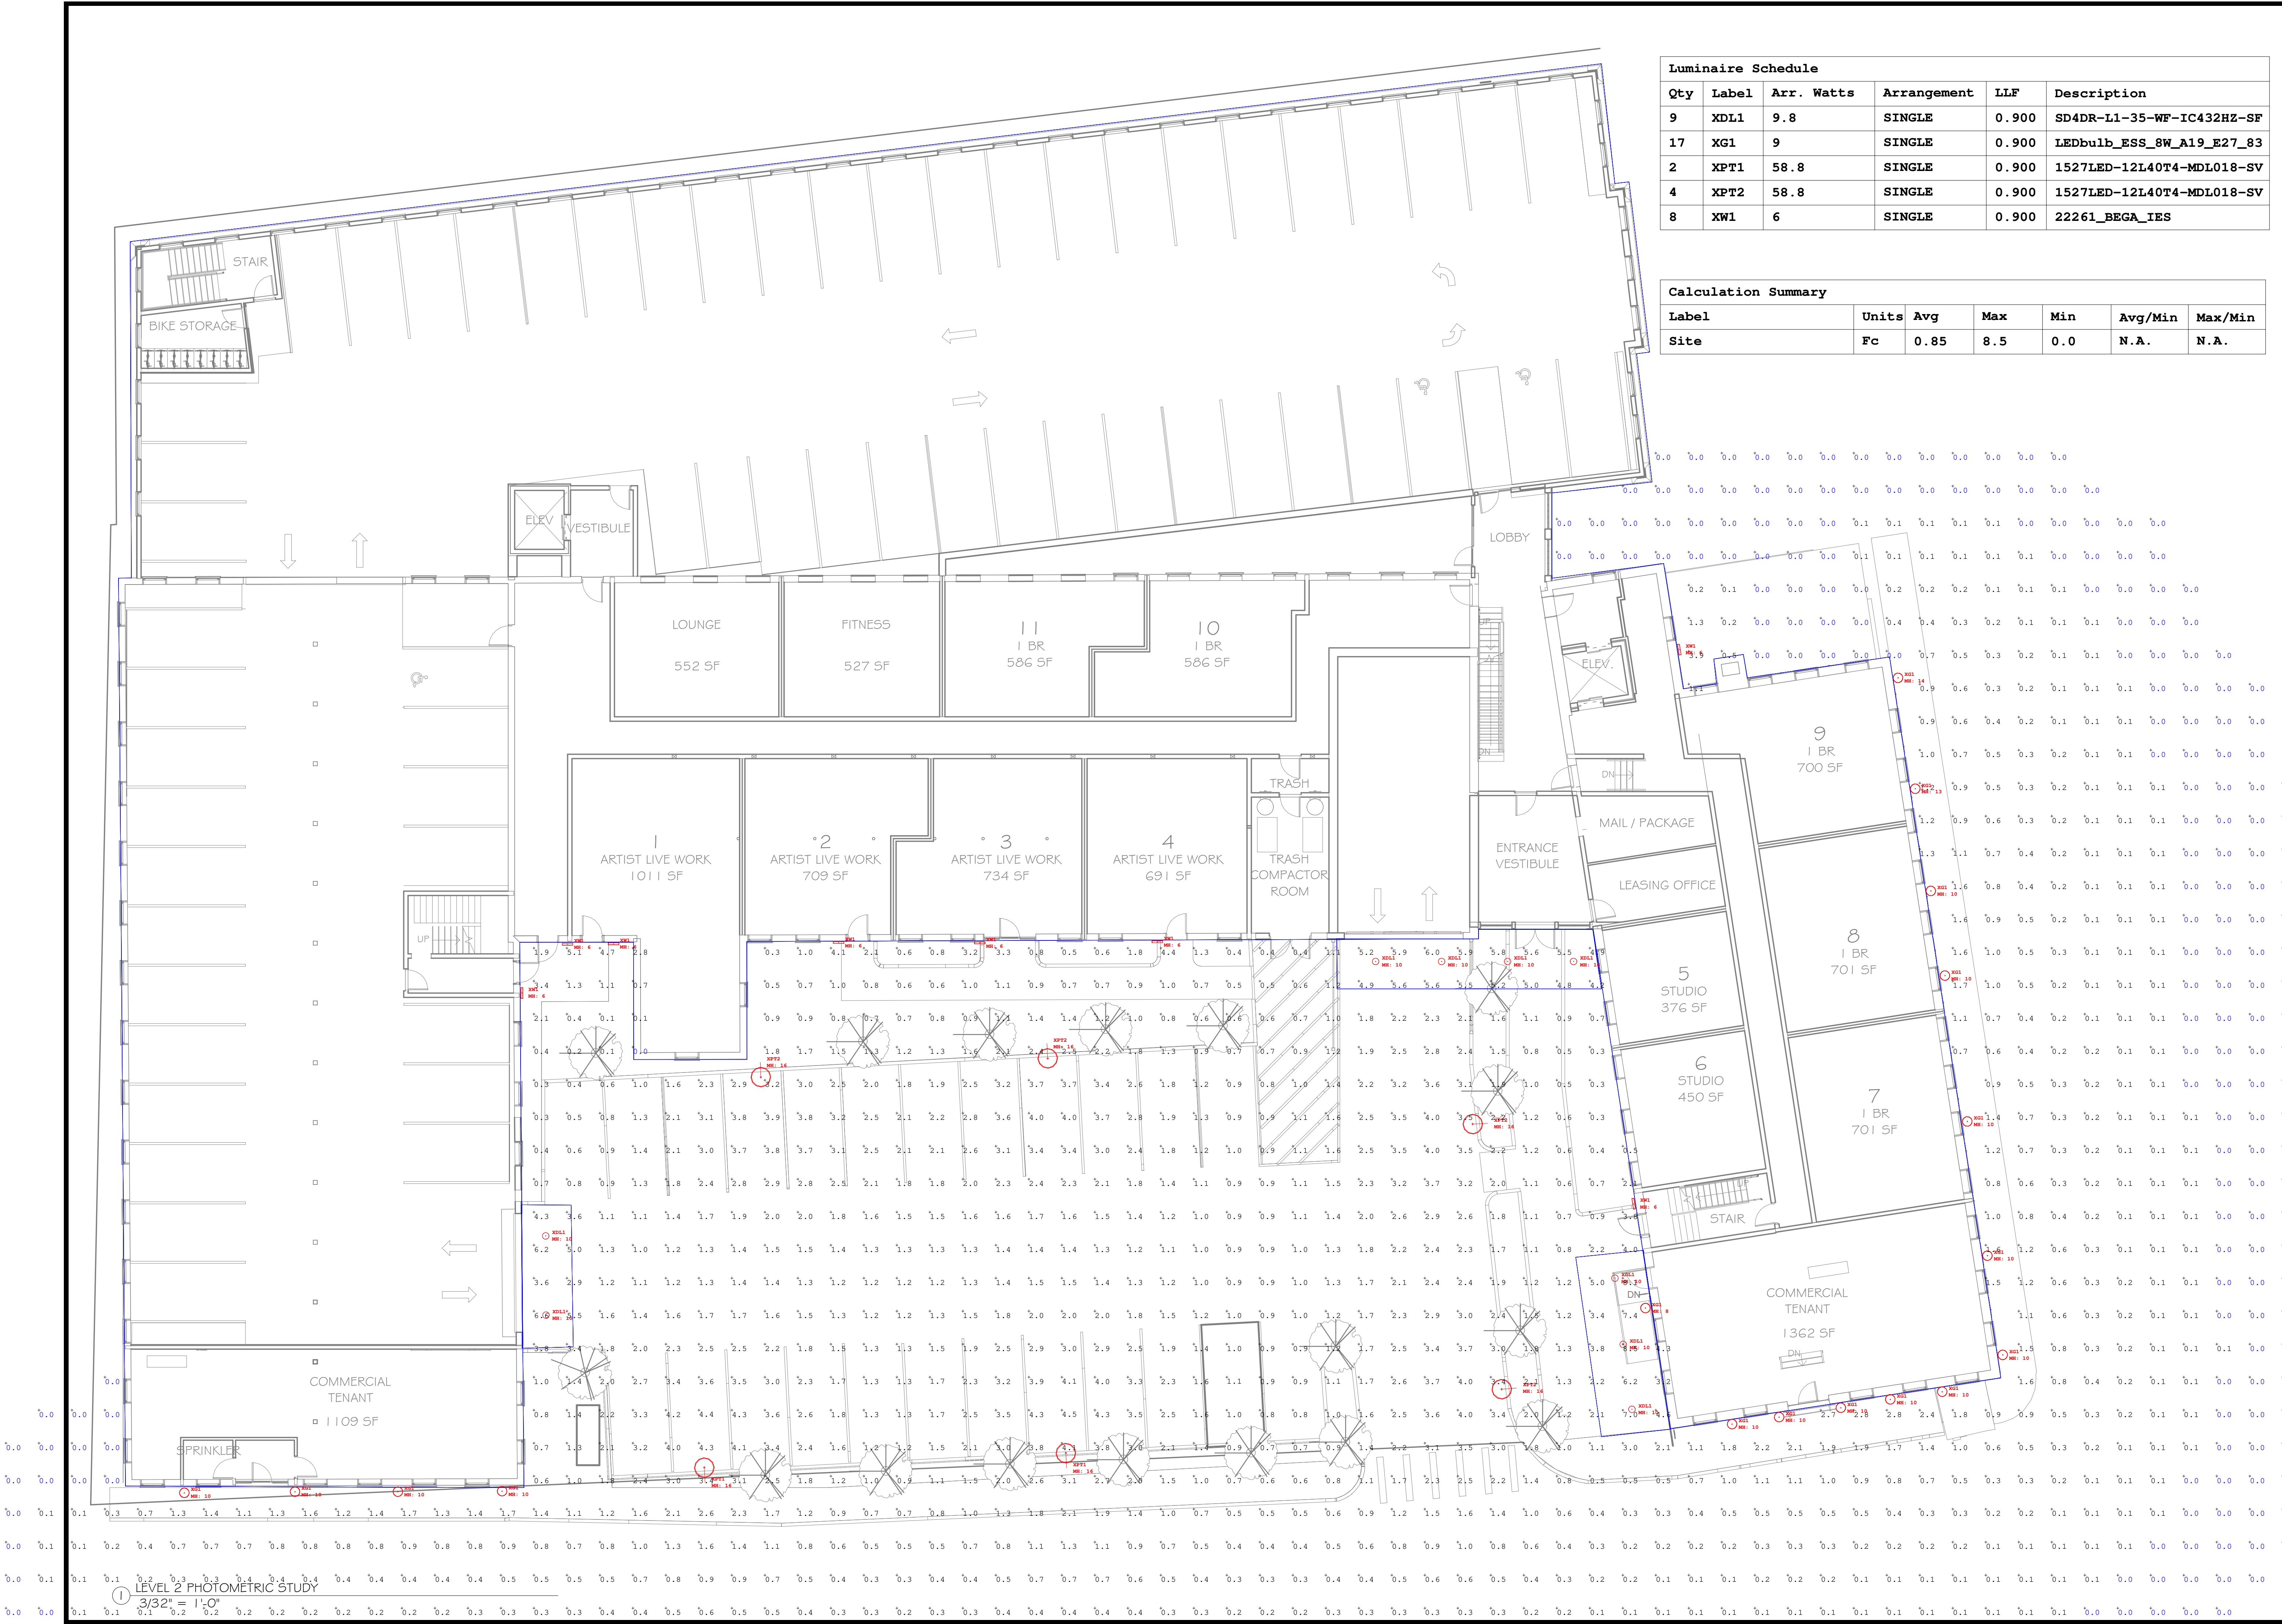

Luminaire Schedule					
Qty	Label	Arr. Watts	Arrangement	LLF	Description
9	XDL1	9.8	SINGLE	0.900	SD4DR-L1-35-WF-IC432HZ-SF
17	XG1	9	SINGLE	0.900	LEDbulb_ESS_8W_A19_E27_83
2	XPT1	58.8	SINGLE	0.900	1527LED-12L40T4-MDL018-SV
4	XPT2	58.8	SINGLE	0.900	1527LED-12L40T4-MDL018-SV
8	XW1	6	SINGLE	0.900	22261_BEGA_IES

Calculation Summary						
Label	Units	Avg	Max	Min	Avg/Min	Max/Min
Site	Fc	0.85	8.5	0.0	N.A.	N.A.

March 9, 2026
Checked By

Issue Date:
Description

Revisions

PHOTOMETRIC STUDY

9 OAKLAND STREET AMESBURY LLC
9 Oakland Street Amesbury, MA 01913

SV DESIGN
126 Dodge Street
Beverly, Massachusetts 01915
www.svdesign.com
t 978.927.3745




Scale: 3/32" = 1'-0"
Drawn By: Author
Date: March 9, 2026

Checked By: Checker
Project #: 116122007

DESIGN

PHOTOMETRIC STUDY

P101

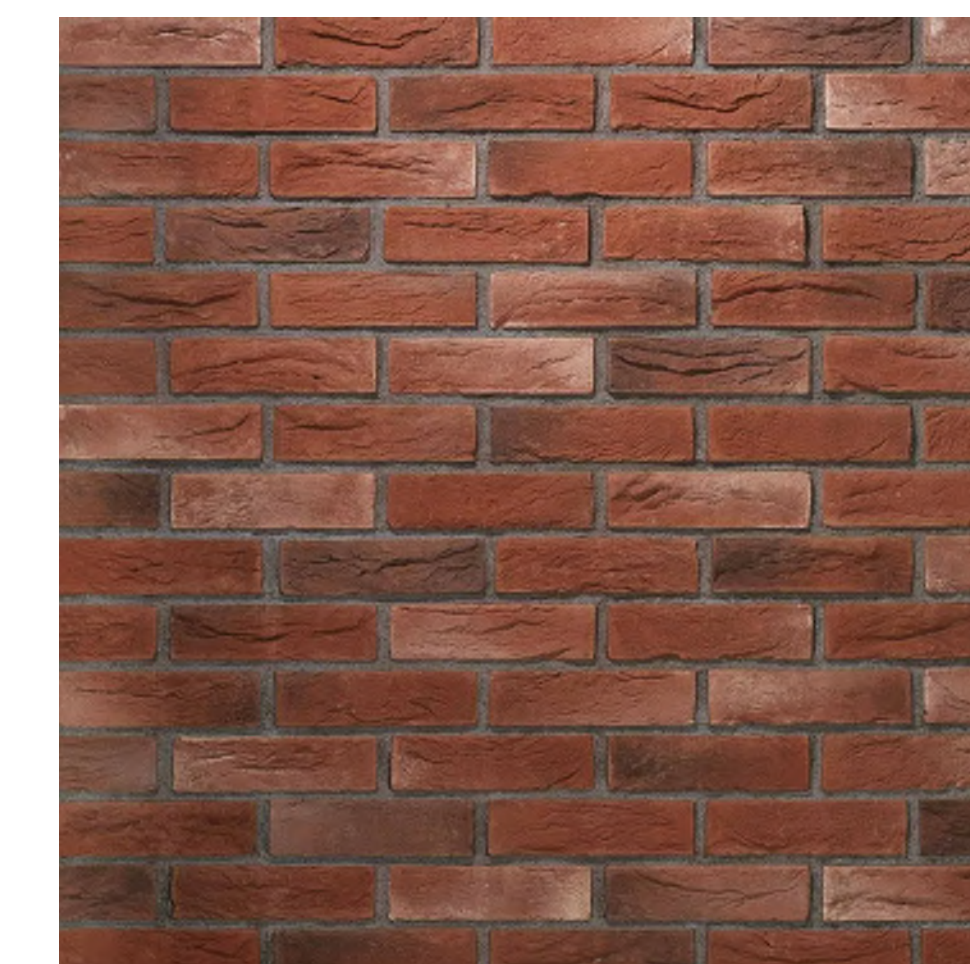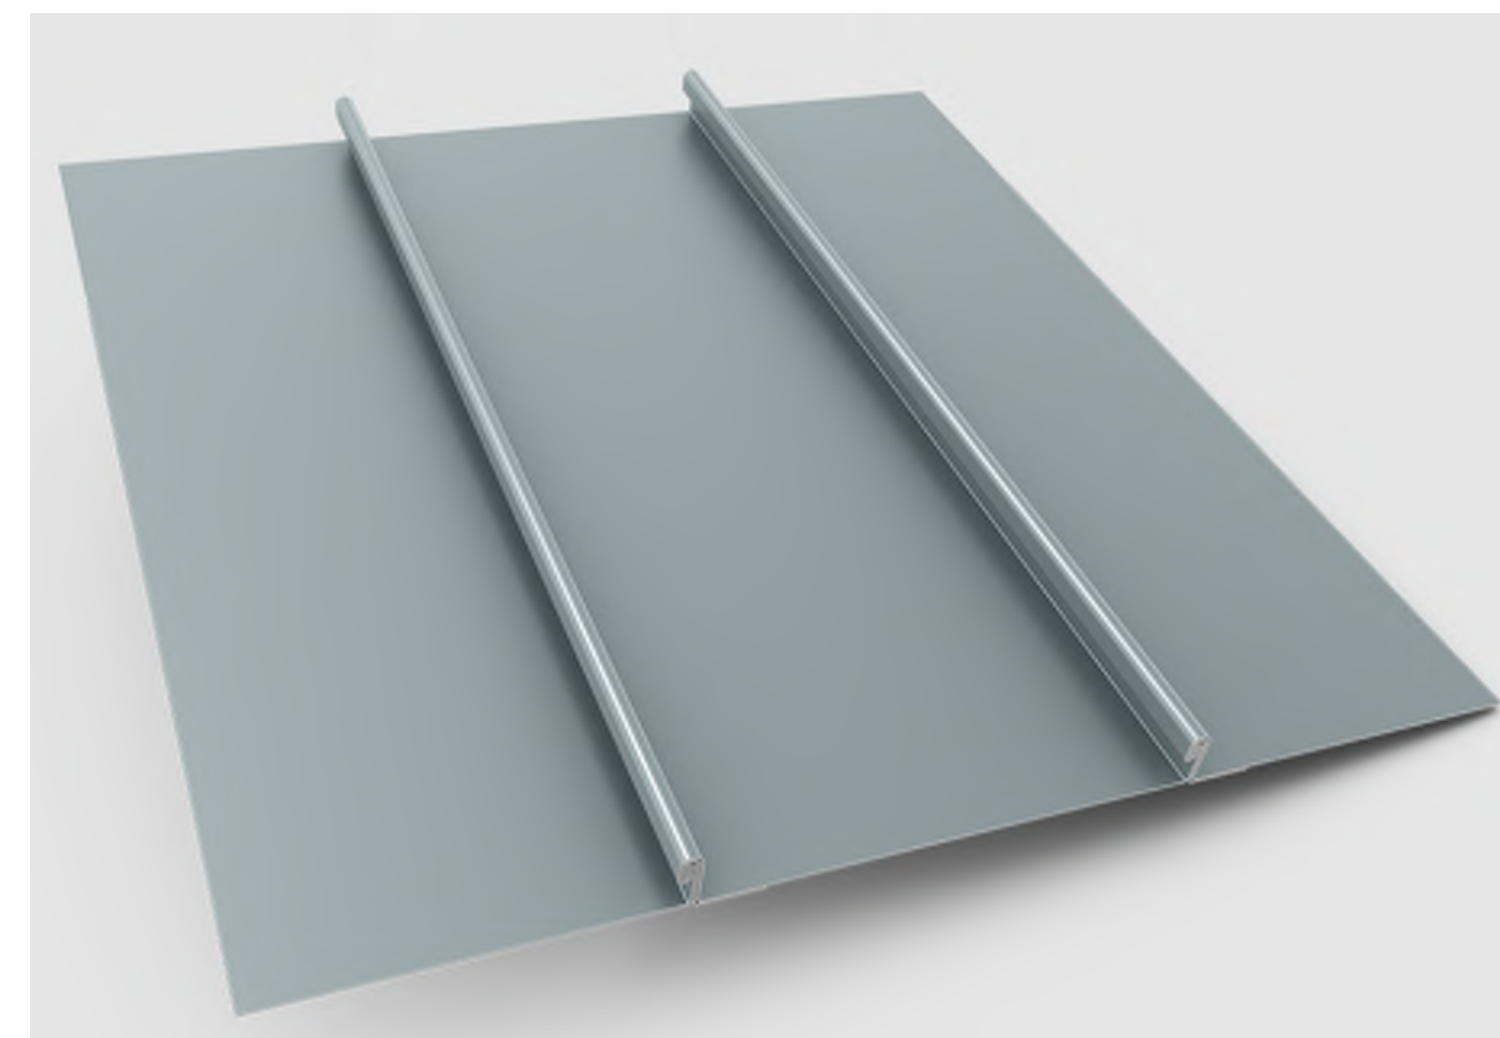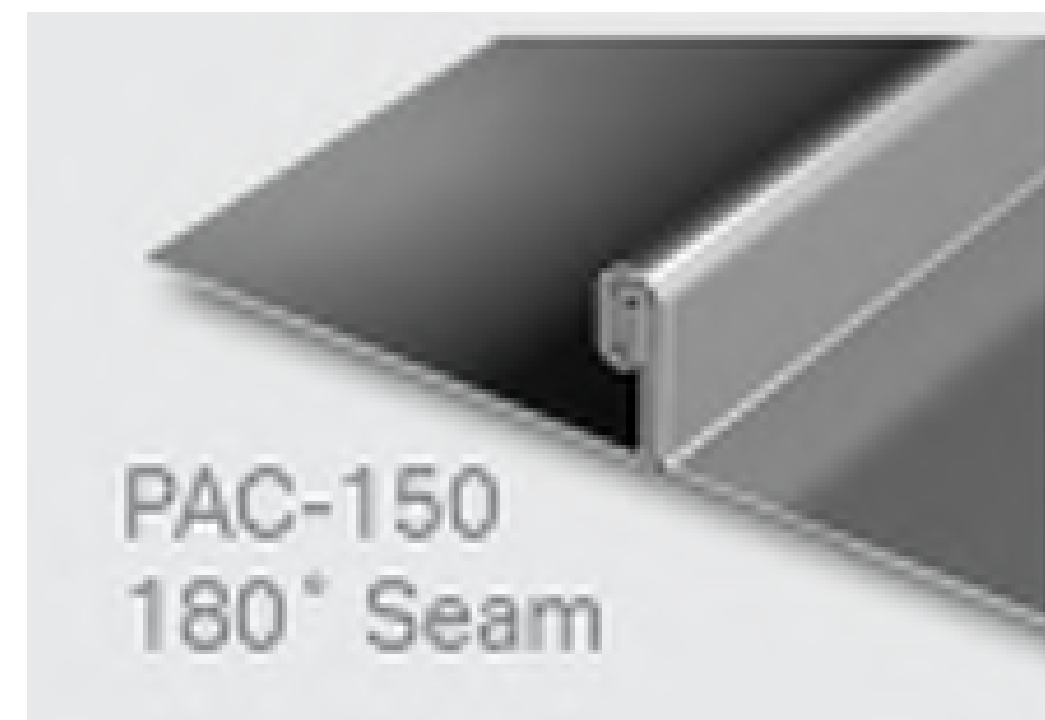[illegible]